




SINGLE DOOR (CONTACT, CAMERA, & PROX READER)

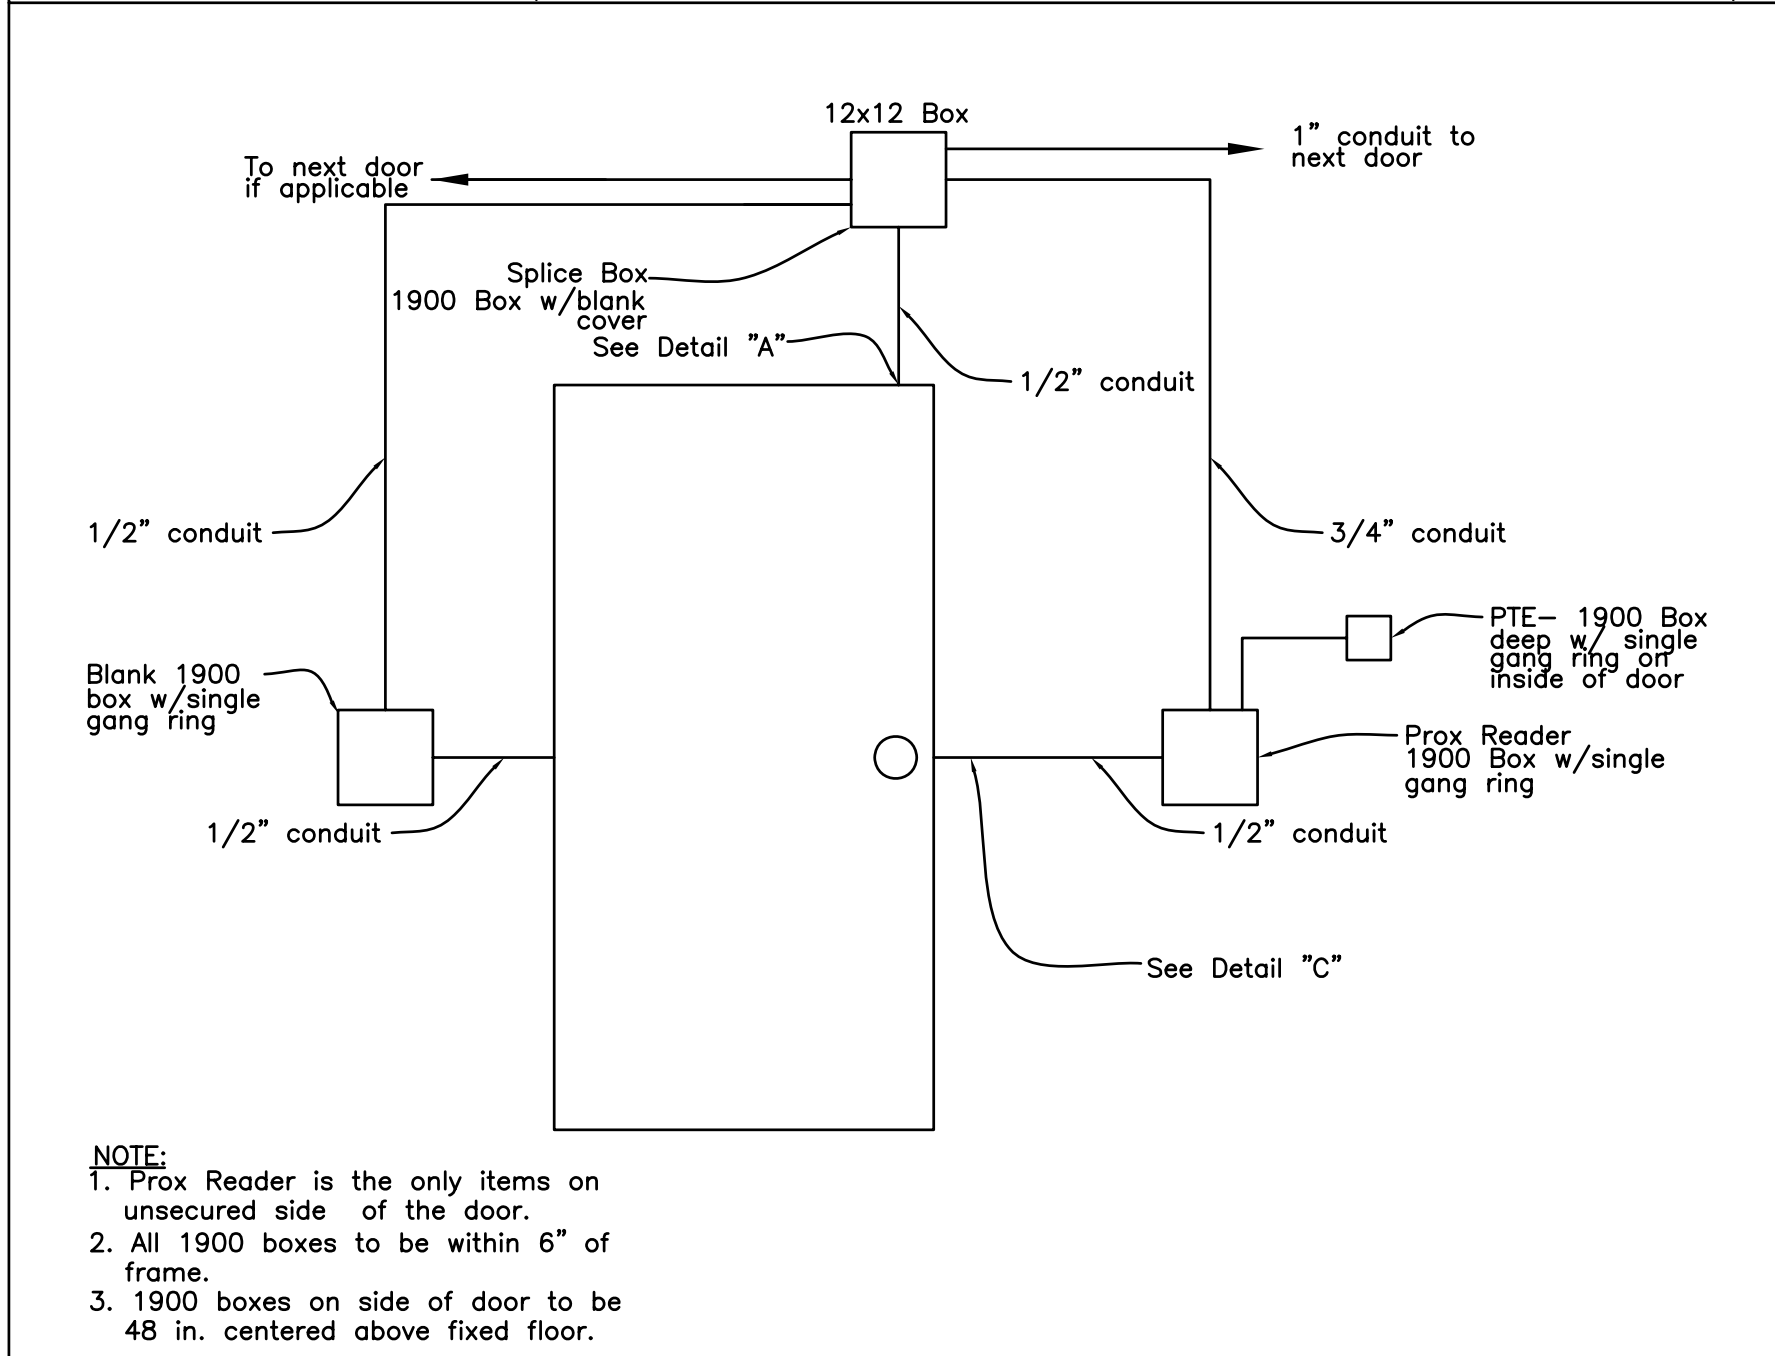


DOUBLE DOOR (CONTACT, PROX READER)

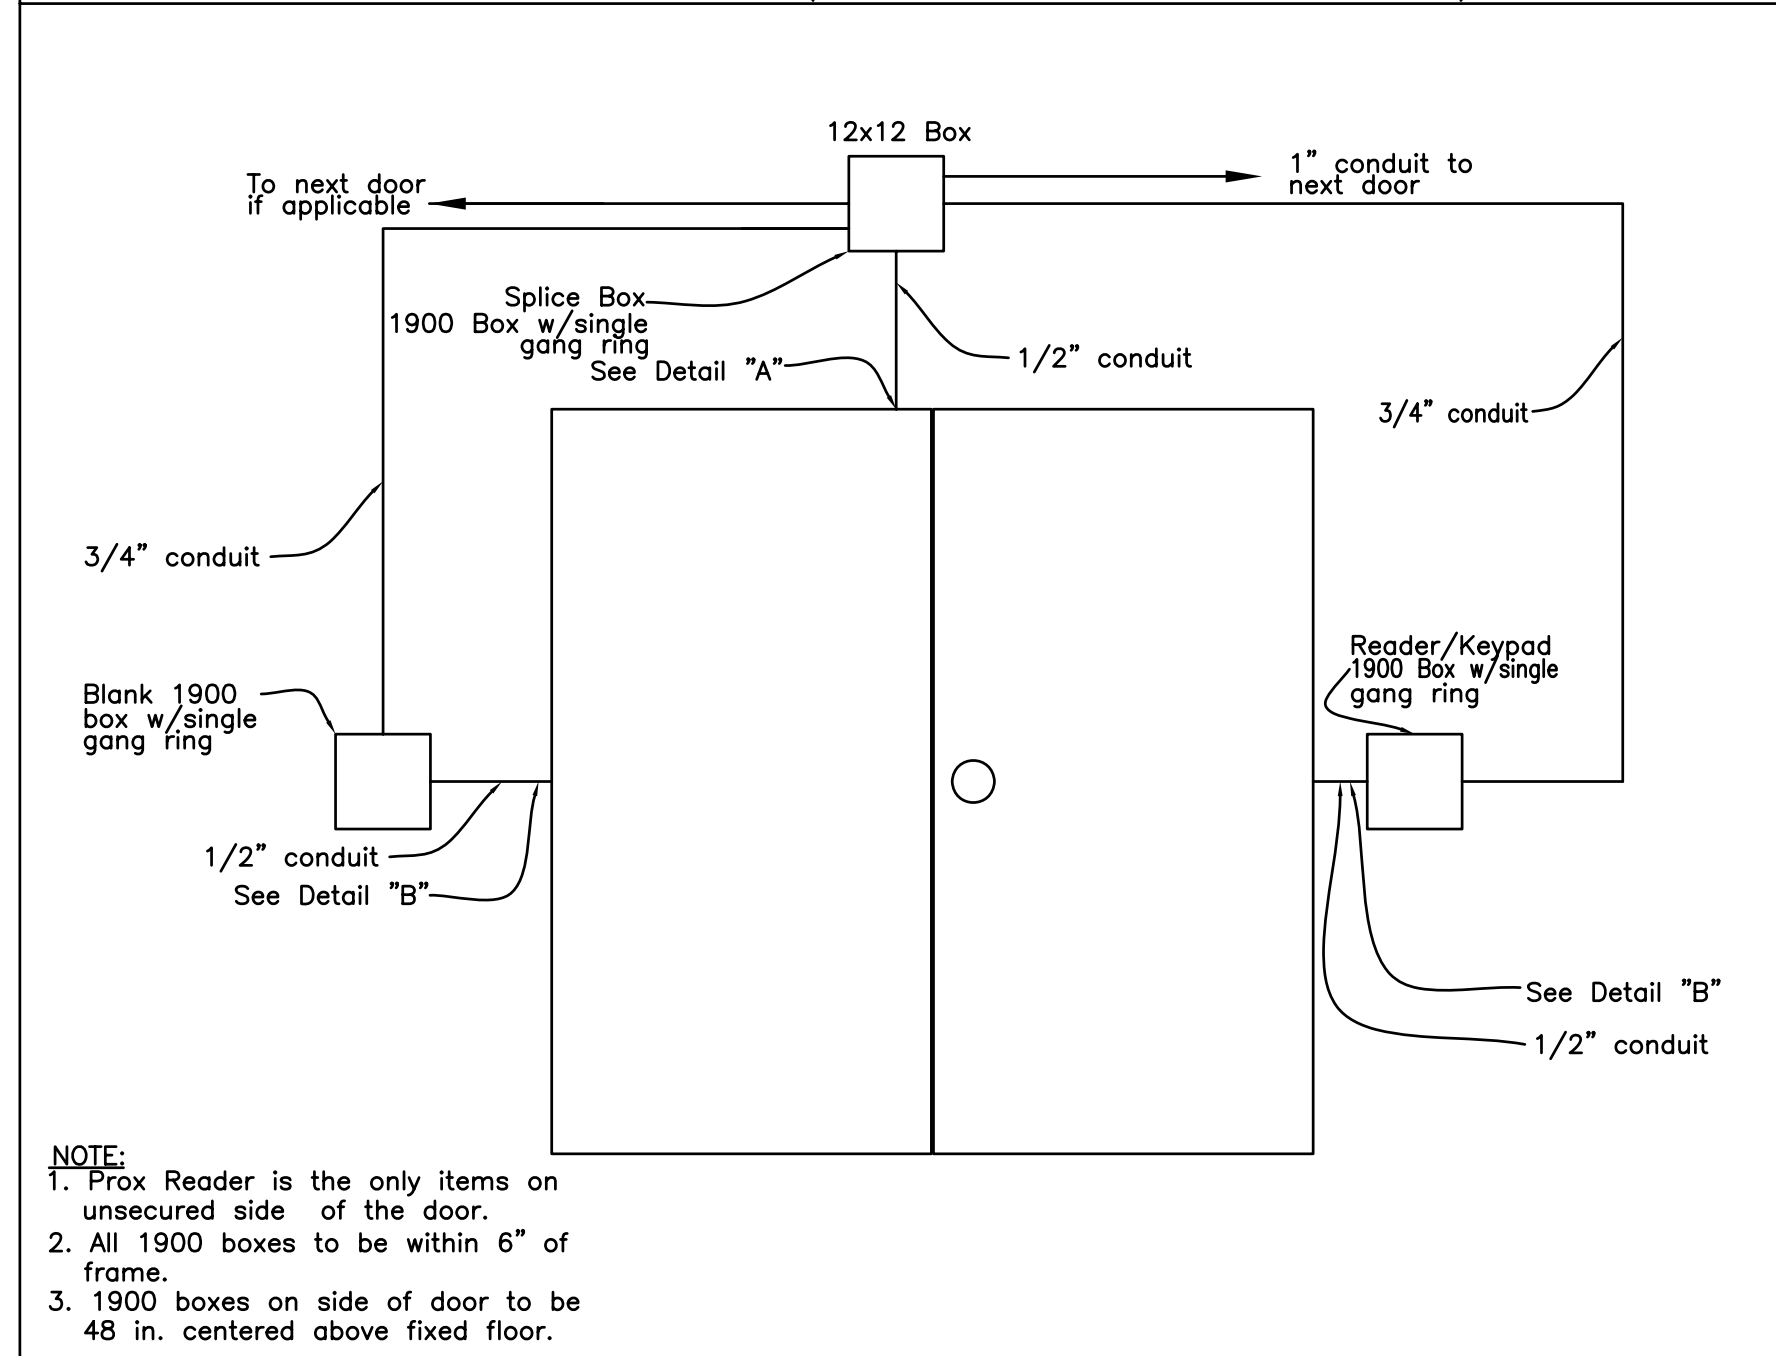


SECURITY ROOM TERMINATION BOARD

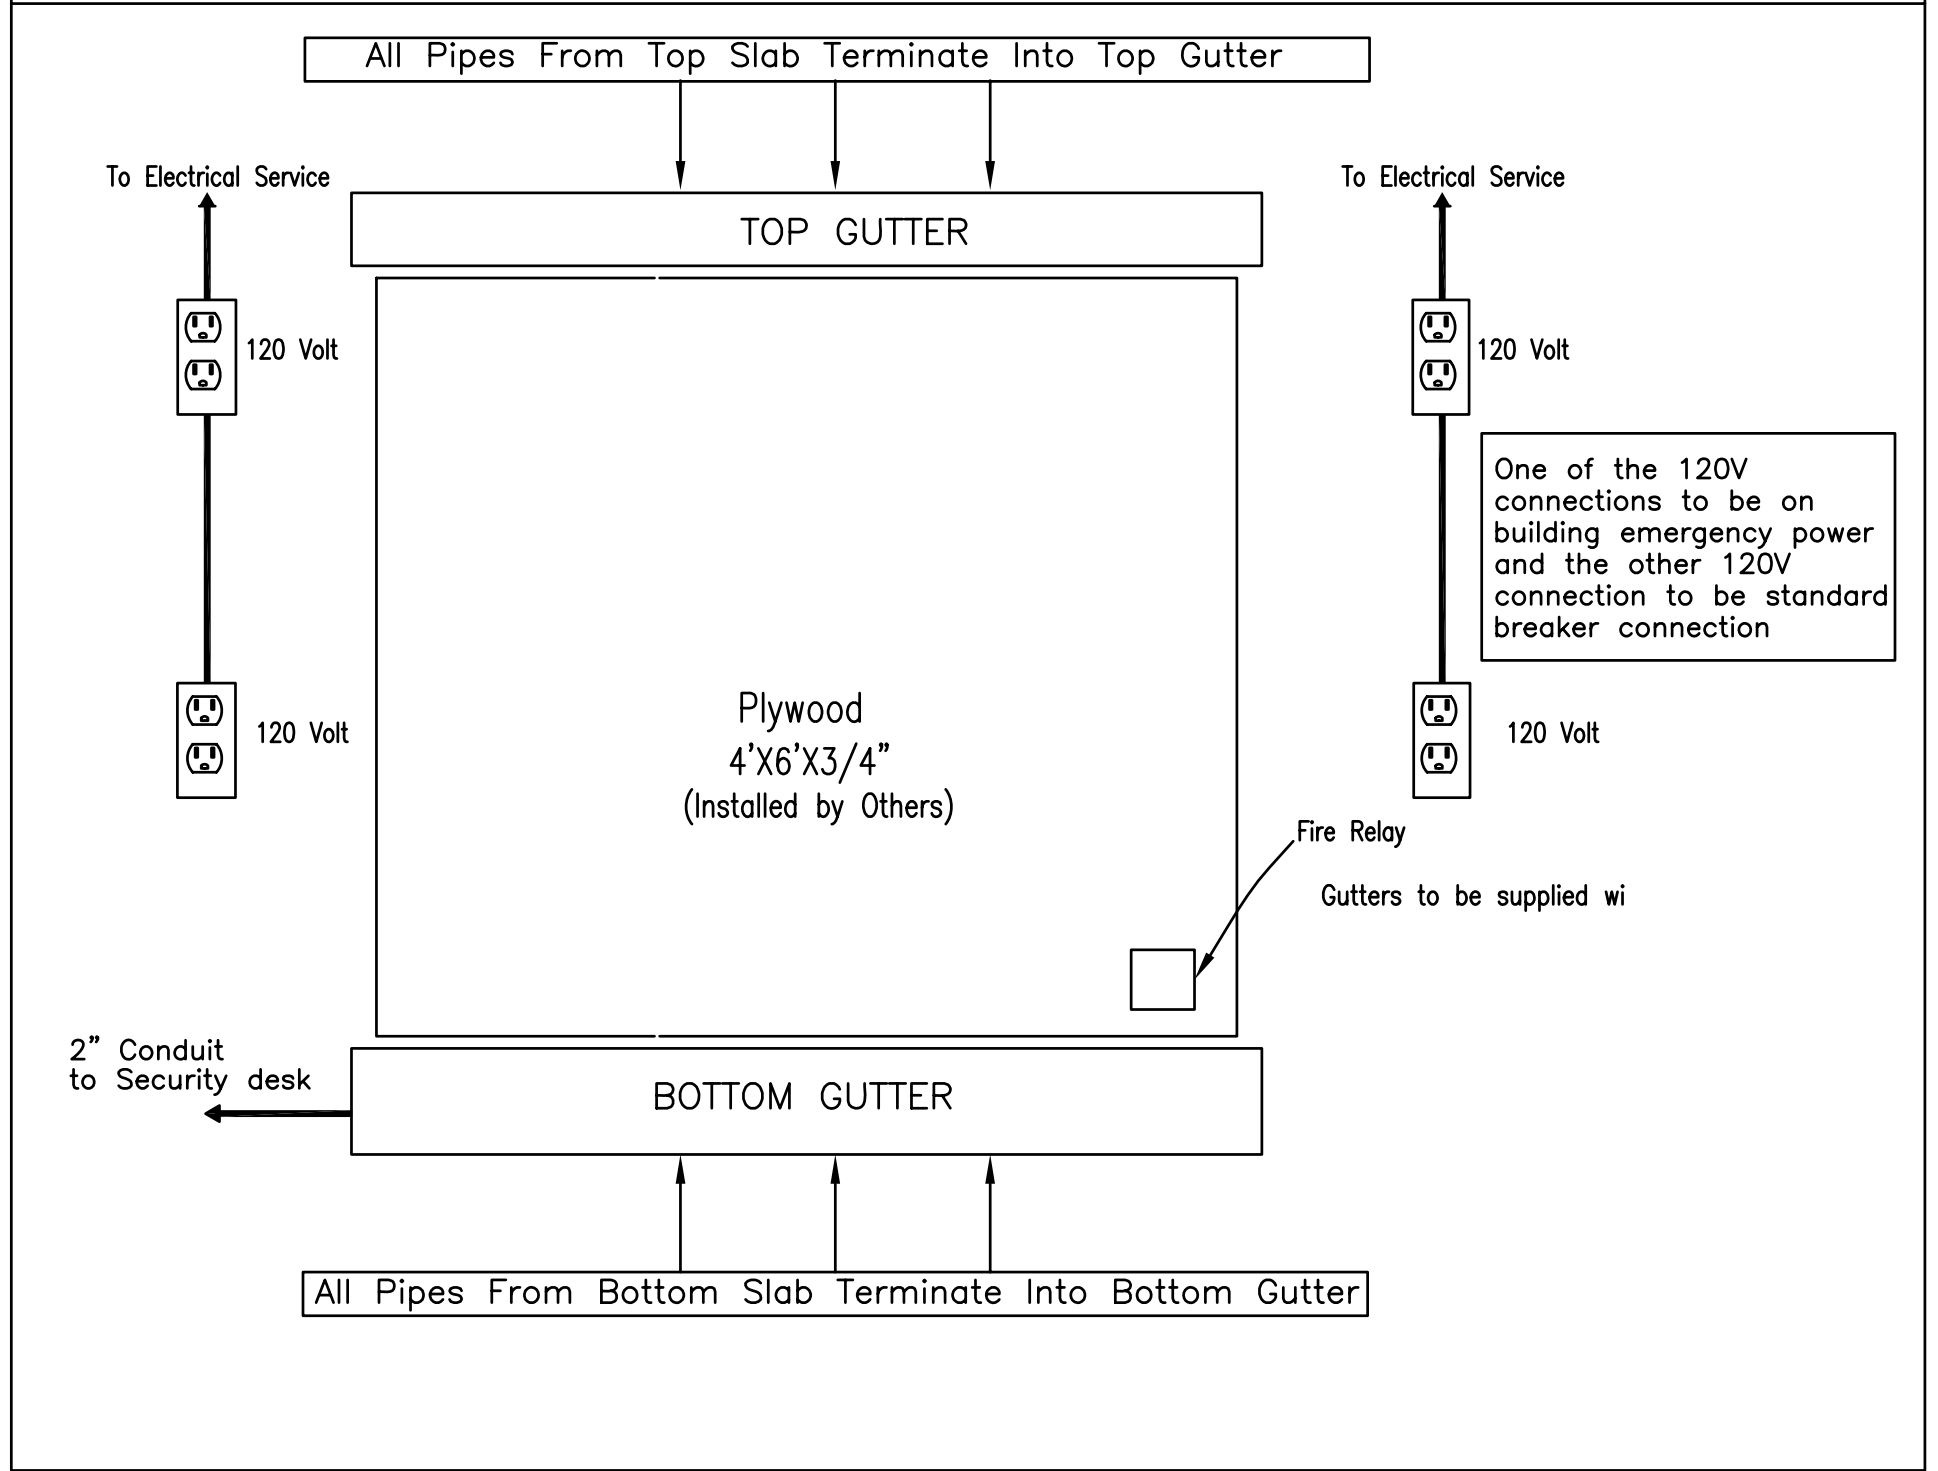


SINGLE DOOR (CONTACT ONLY)

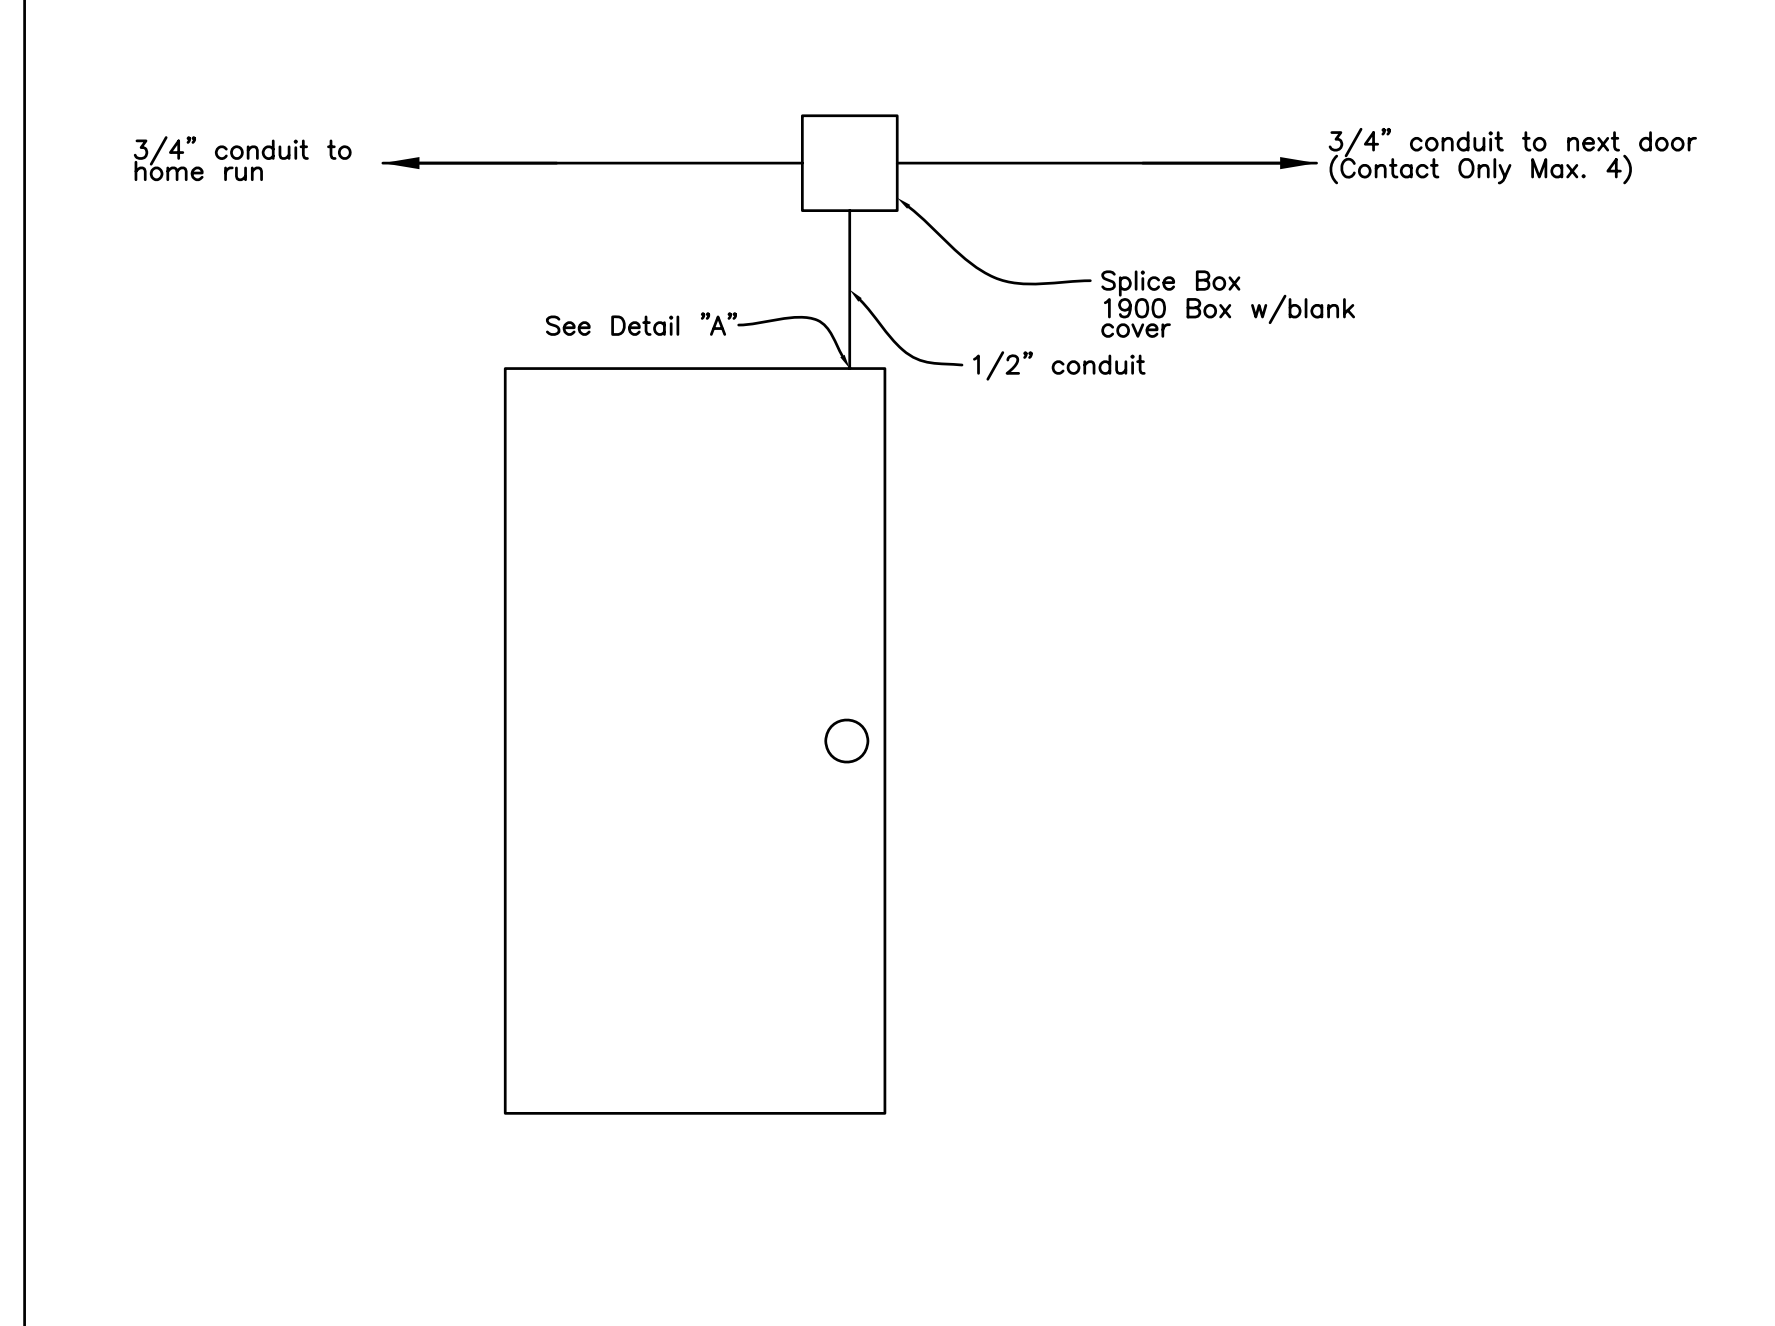



DOUBLE DOOR (CONTACT ONLY)

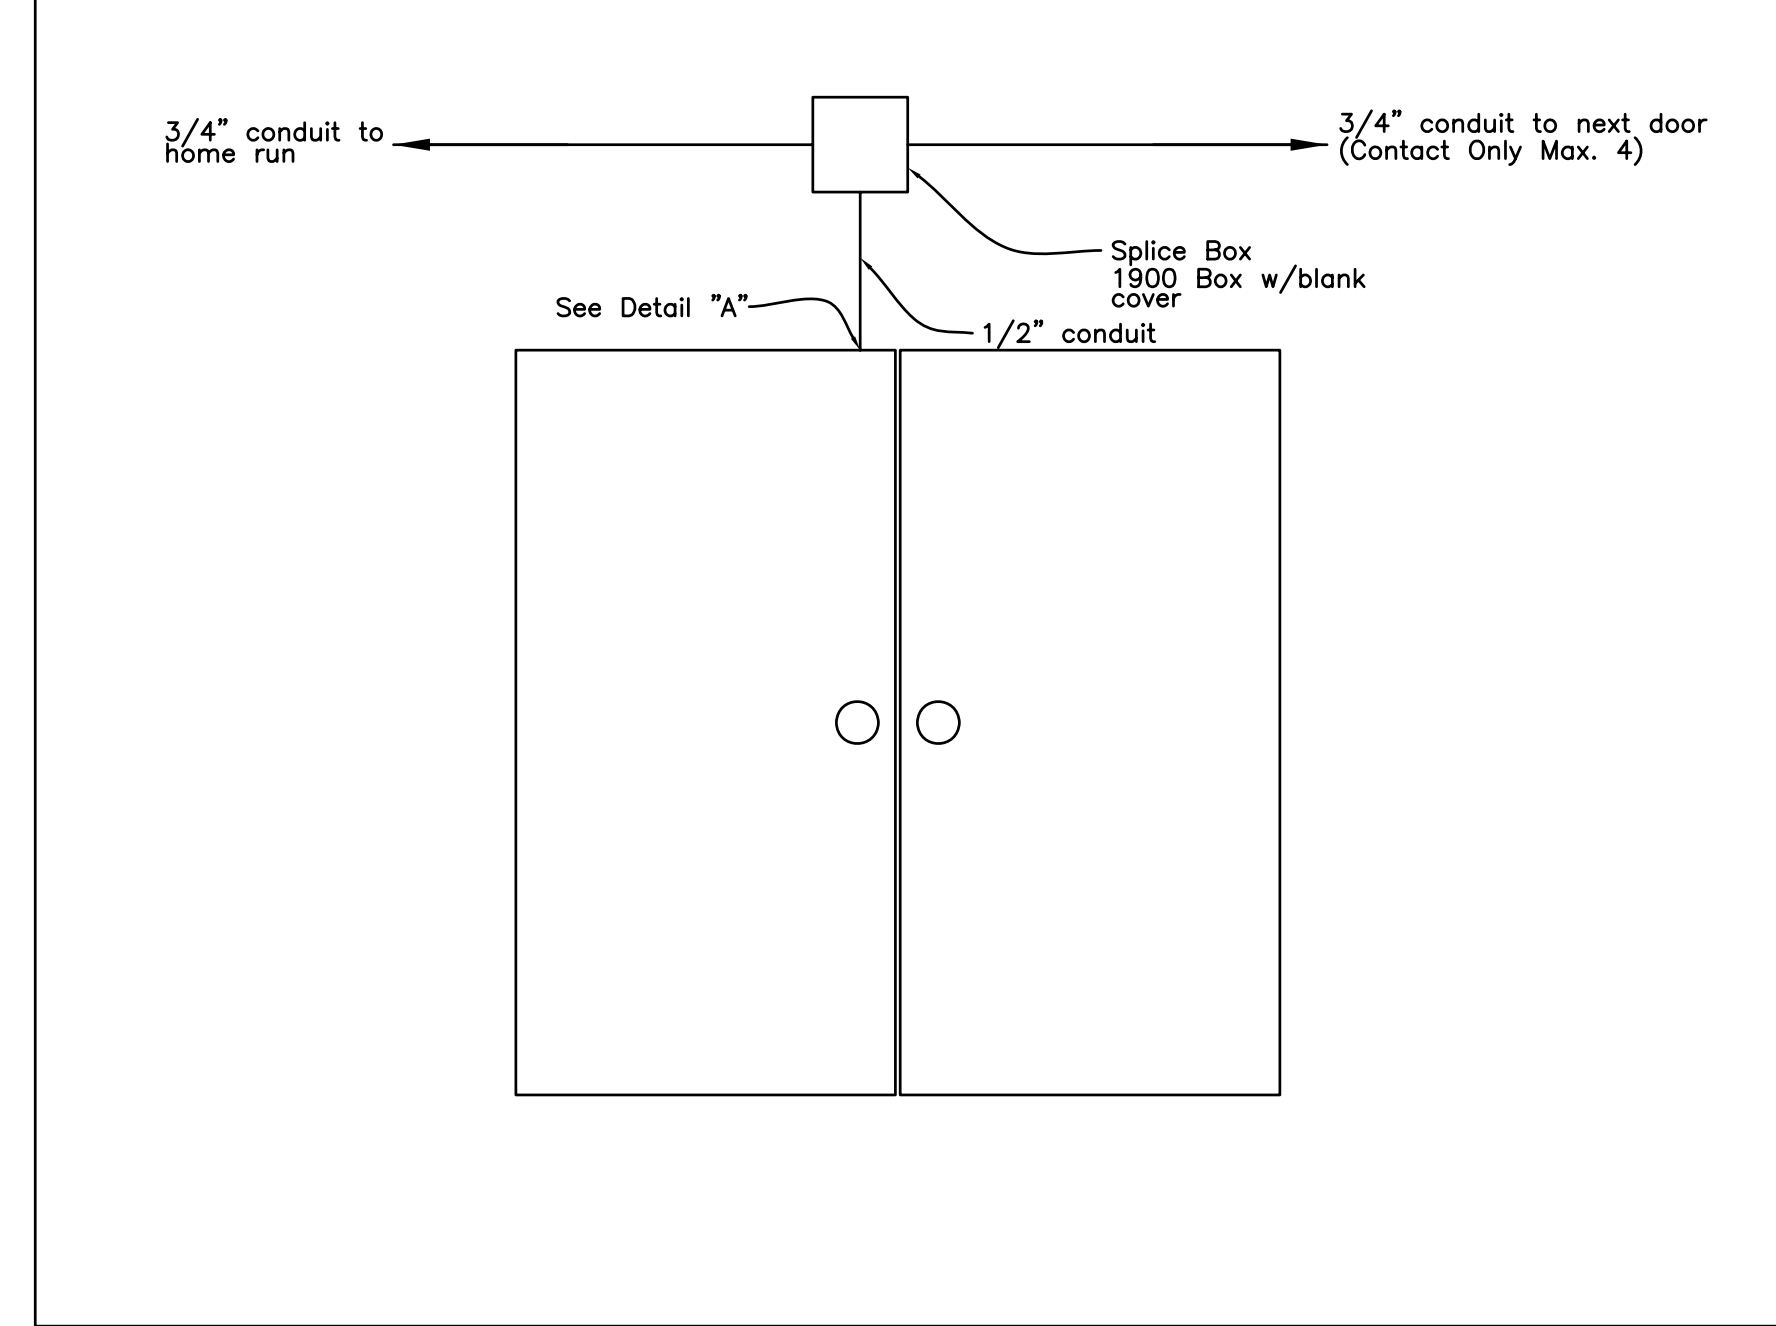


SLIDE GATES

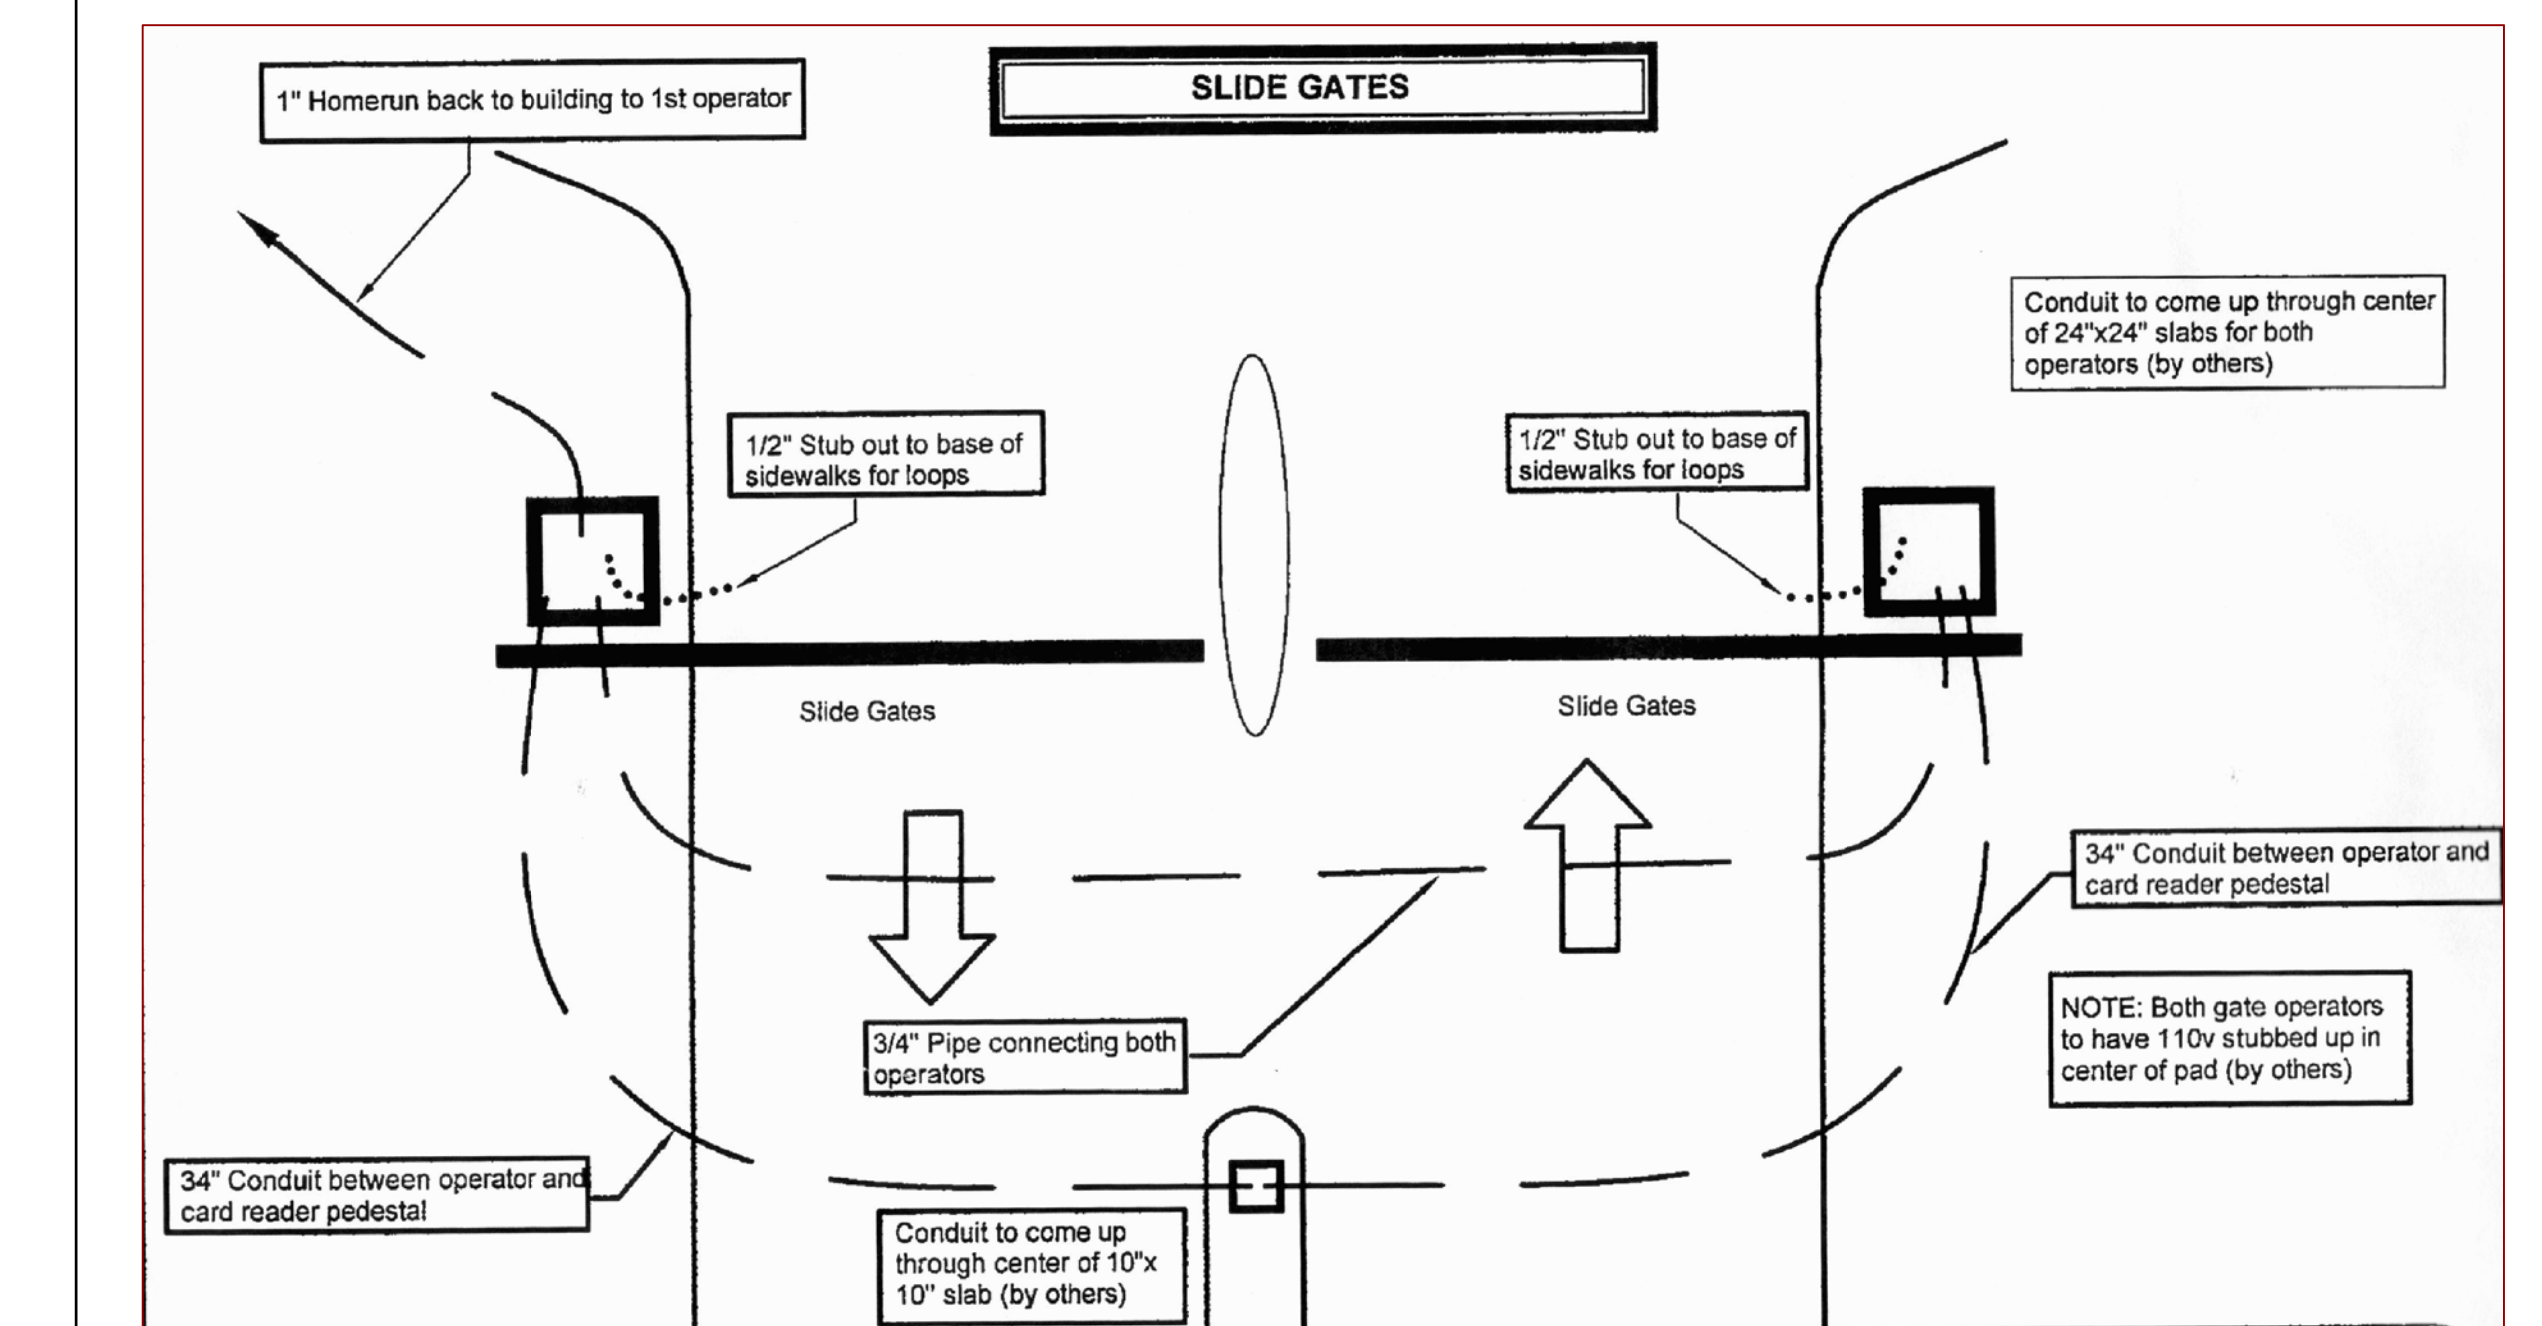

RAMP CARD READER FOR BARRIER GATES

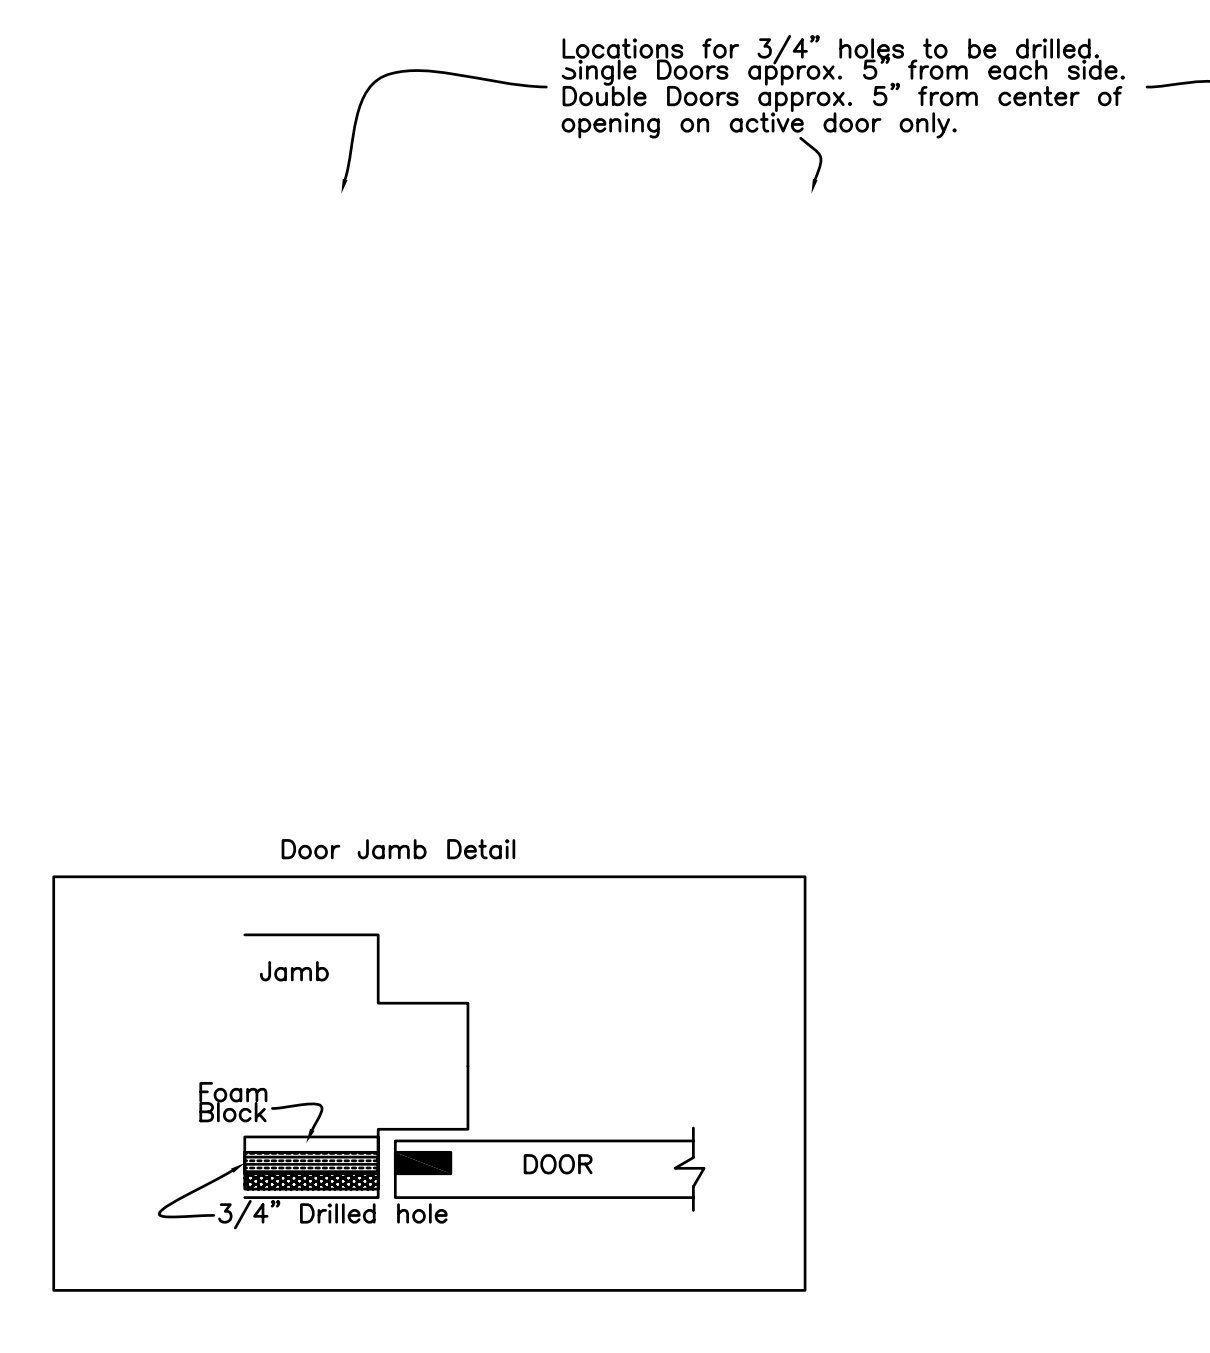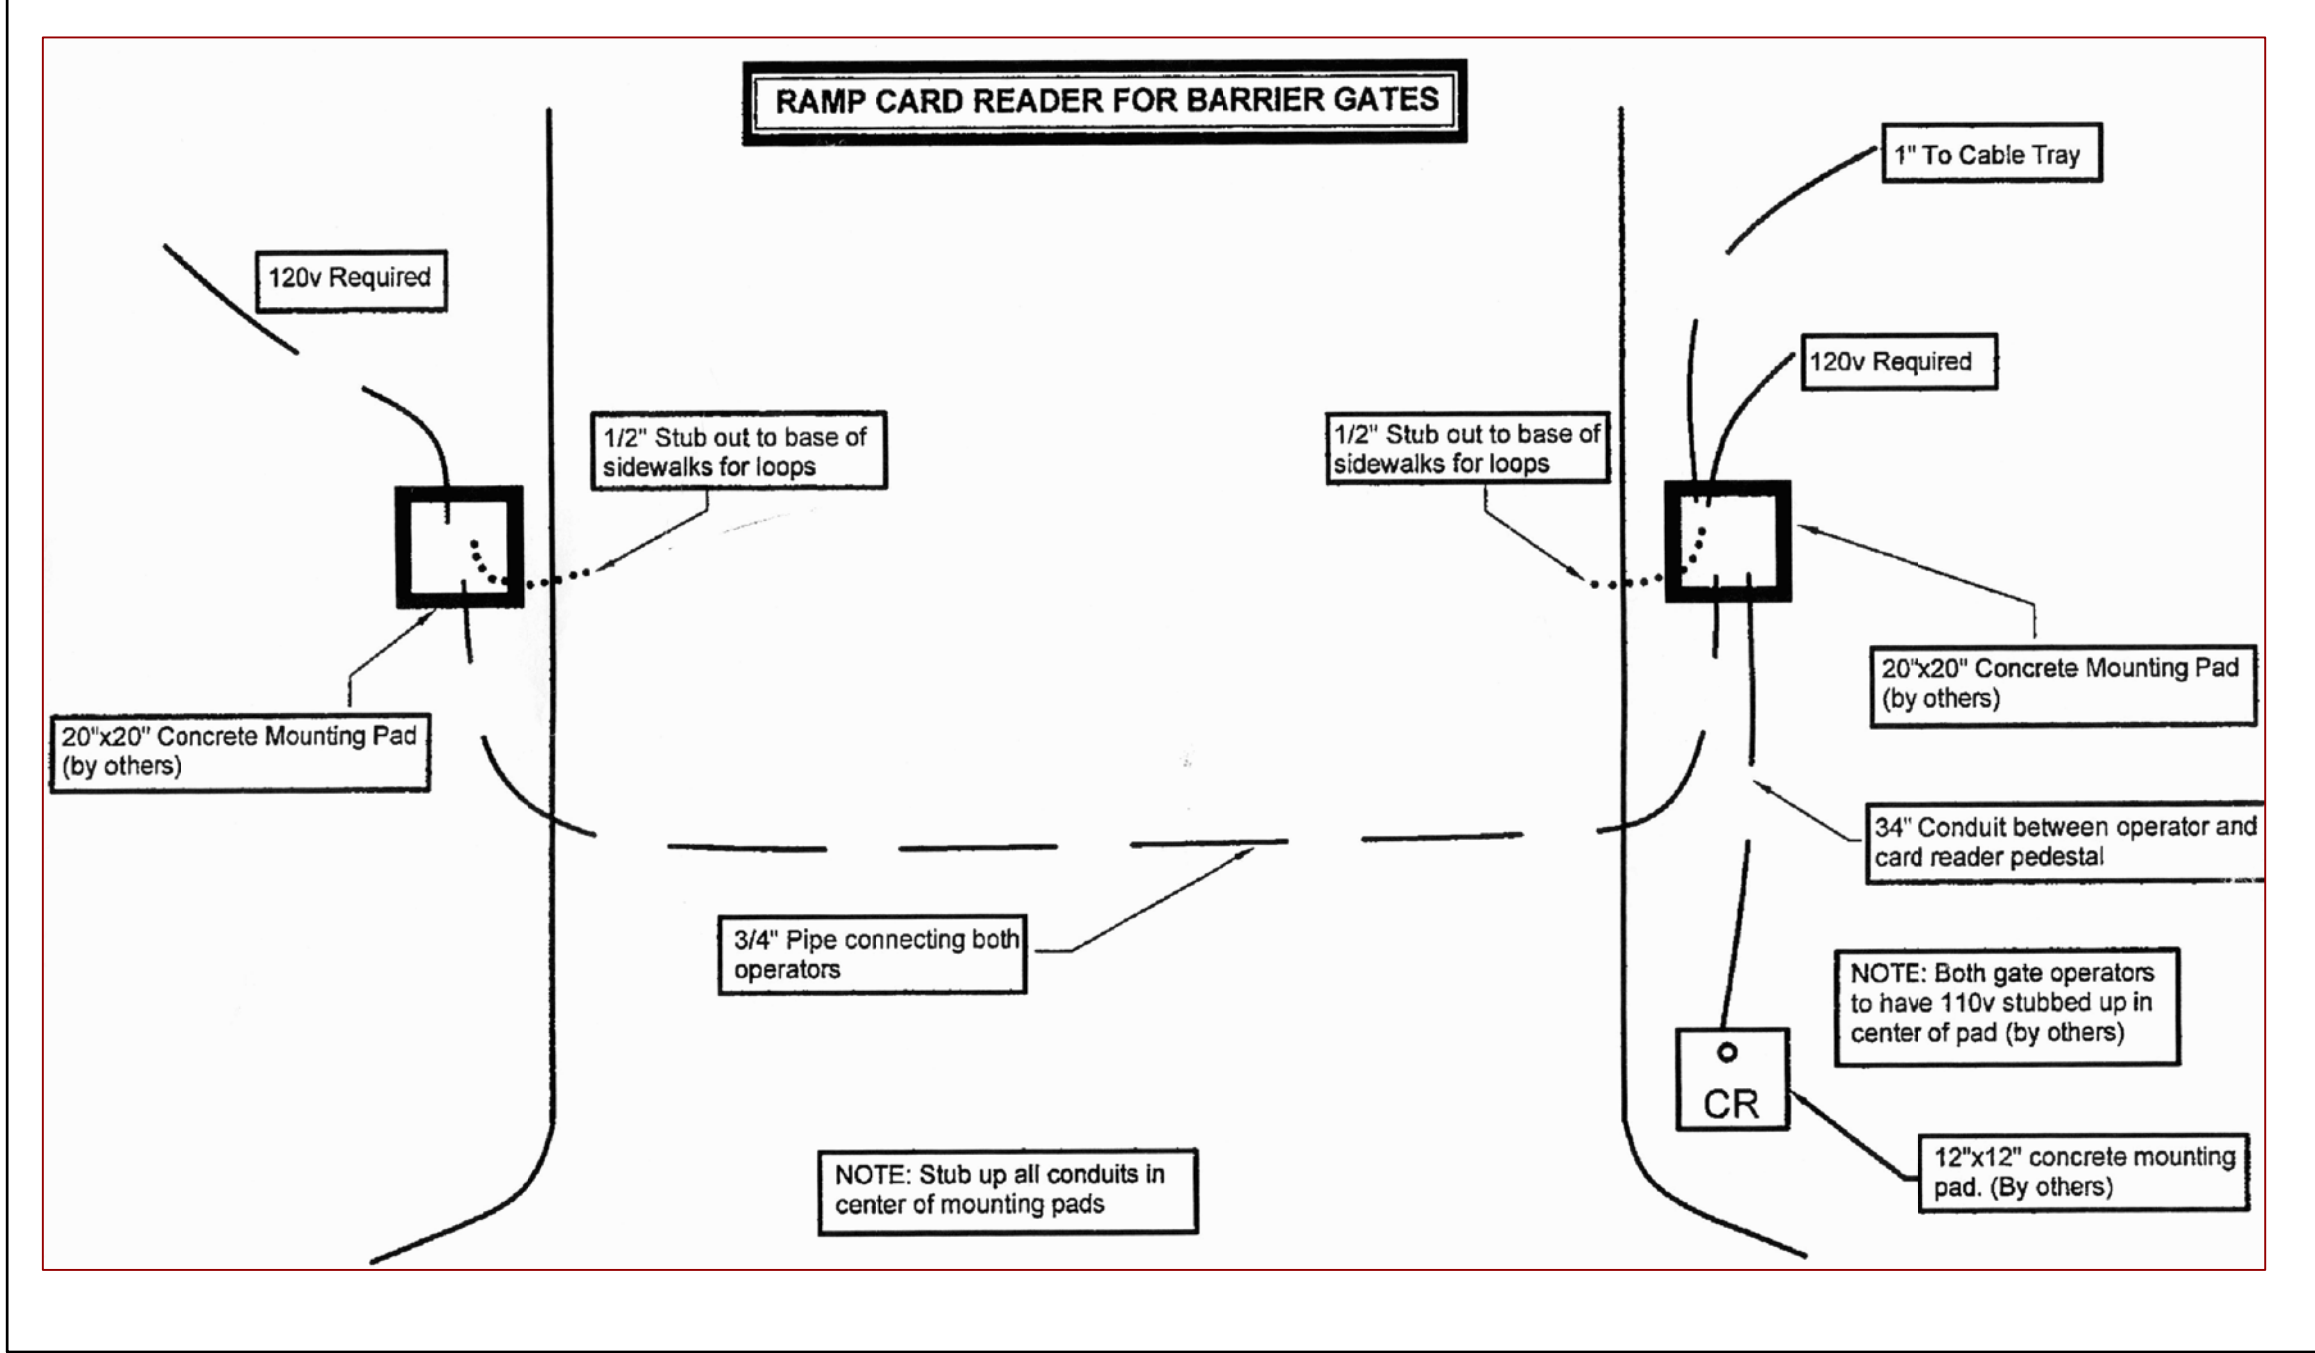

ELEVATOR READER

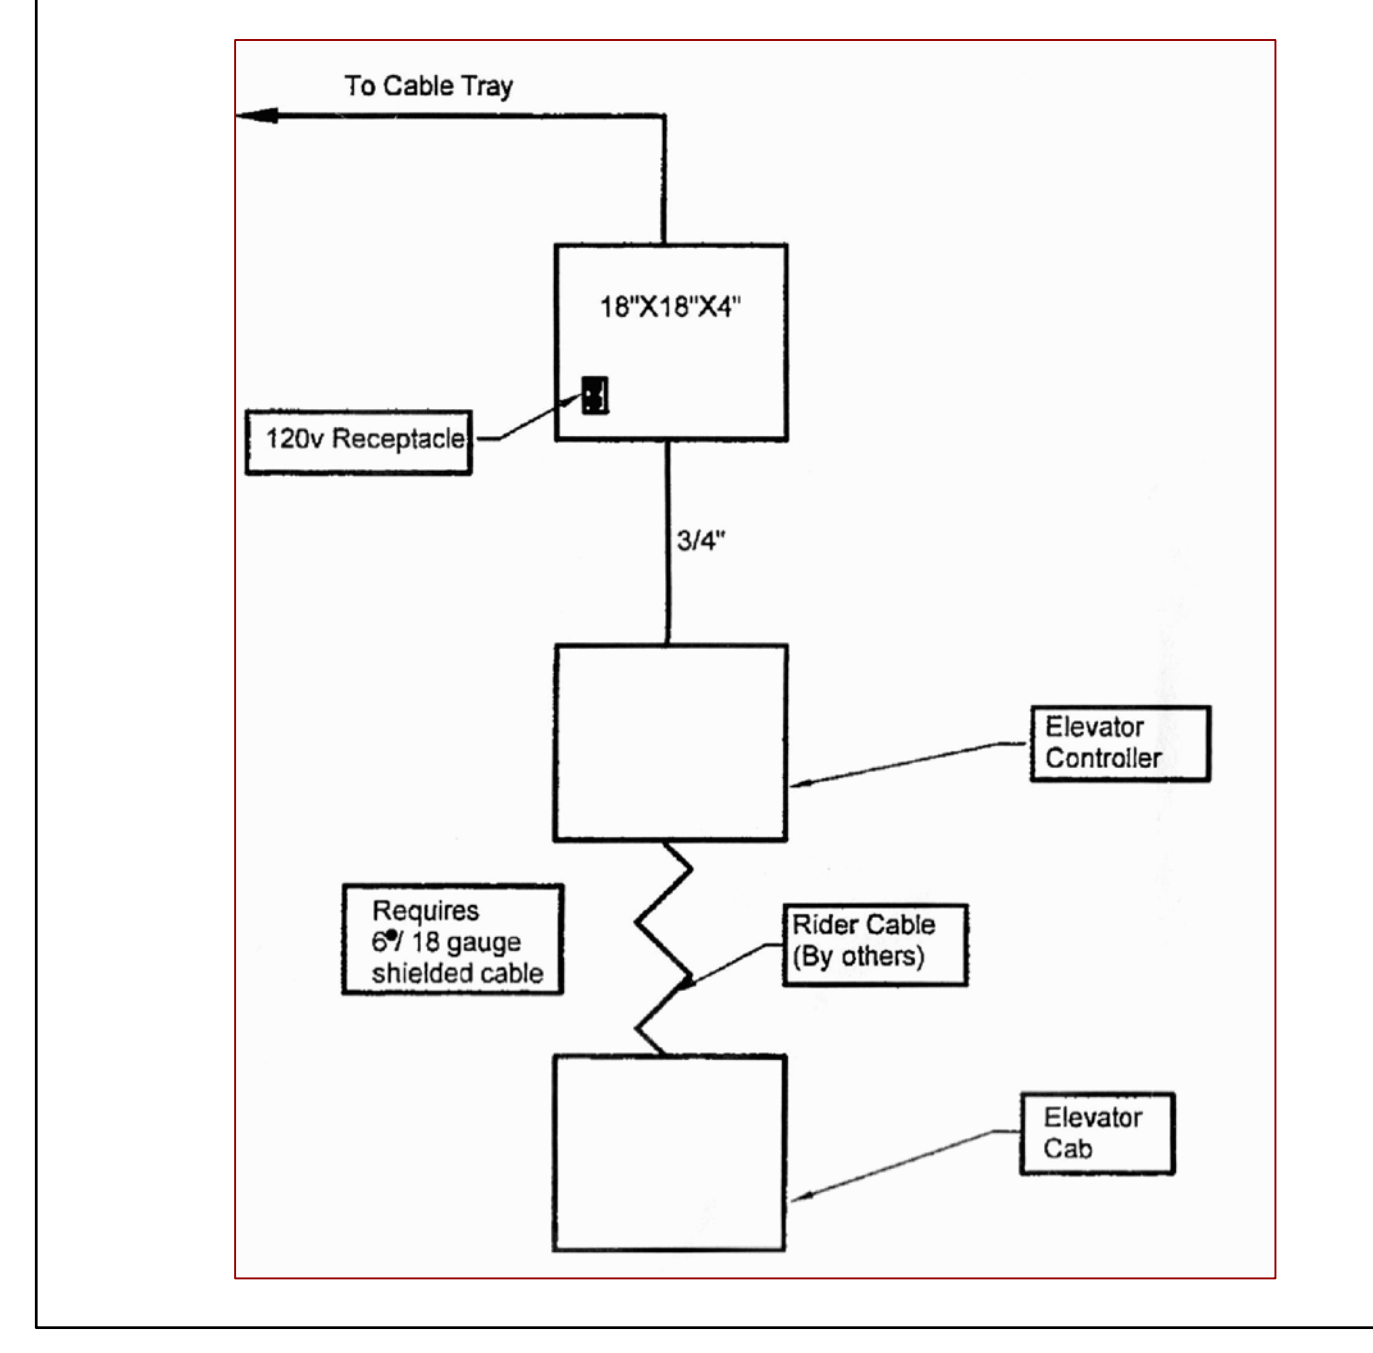

DRAWING TYPE
SECURITY PLAN

Fine Line Engineering Inc.
Electrical, Mechanical, Plumbing
Fire Protection, Construction Administration
1975 W. Sunrise Blvd., Suite #216 Sunrise, FL 33311
www.fl-engineers.com Fax: 954.584.3193
E-mail: cadd@fl-engineers.com
CA# 26819

GEORGE FRENZ, P.E.
Professional Engineer
State of Florida
DATE: _____

Security Innovative Solutions, Inc.
PHONE# (954) 358-0799
FAX# (954) 583-1853
3921 S.W. 47th Avenue, Suite 1009,
DAVIE, FLORIDA 33314
STATE CERTIFIED EF-20000832

SIS

DATE: 04/16/08
APPROVED BY: R.H.
SCALE:
DRAWN BY: S.V.
CHECKED BY: M.G.
SHEET SEC - 5